


P:\Discovery Midstream\17009 - Discovery Phase II Detailed Engineering\CAD\STA\SHS\Gen\17009-G-XXXX.dwg Jeff Hillman 3/8/2017 2:13:44 PM

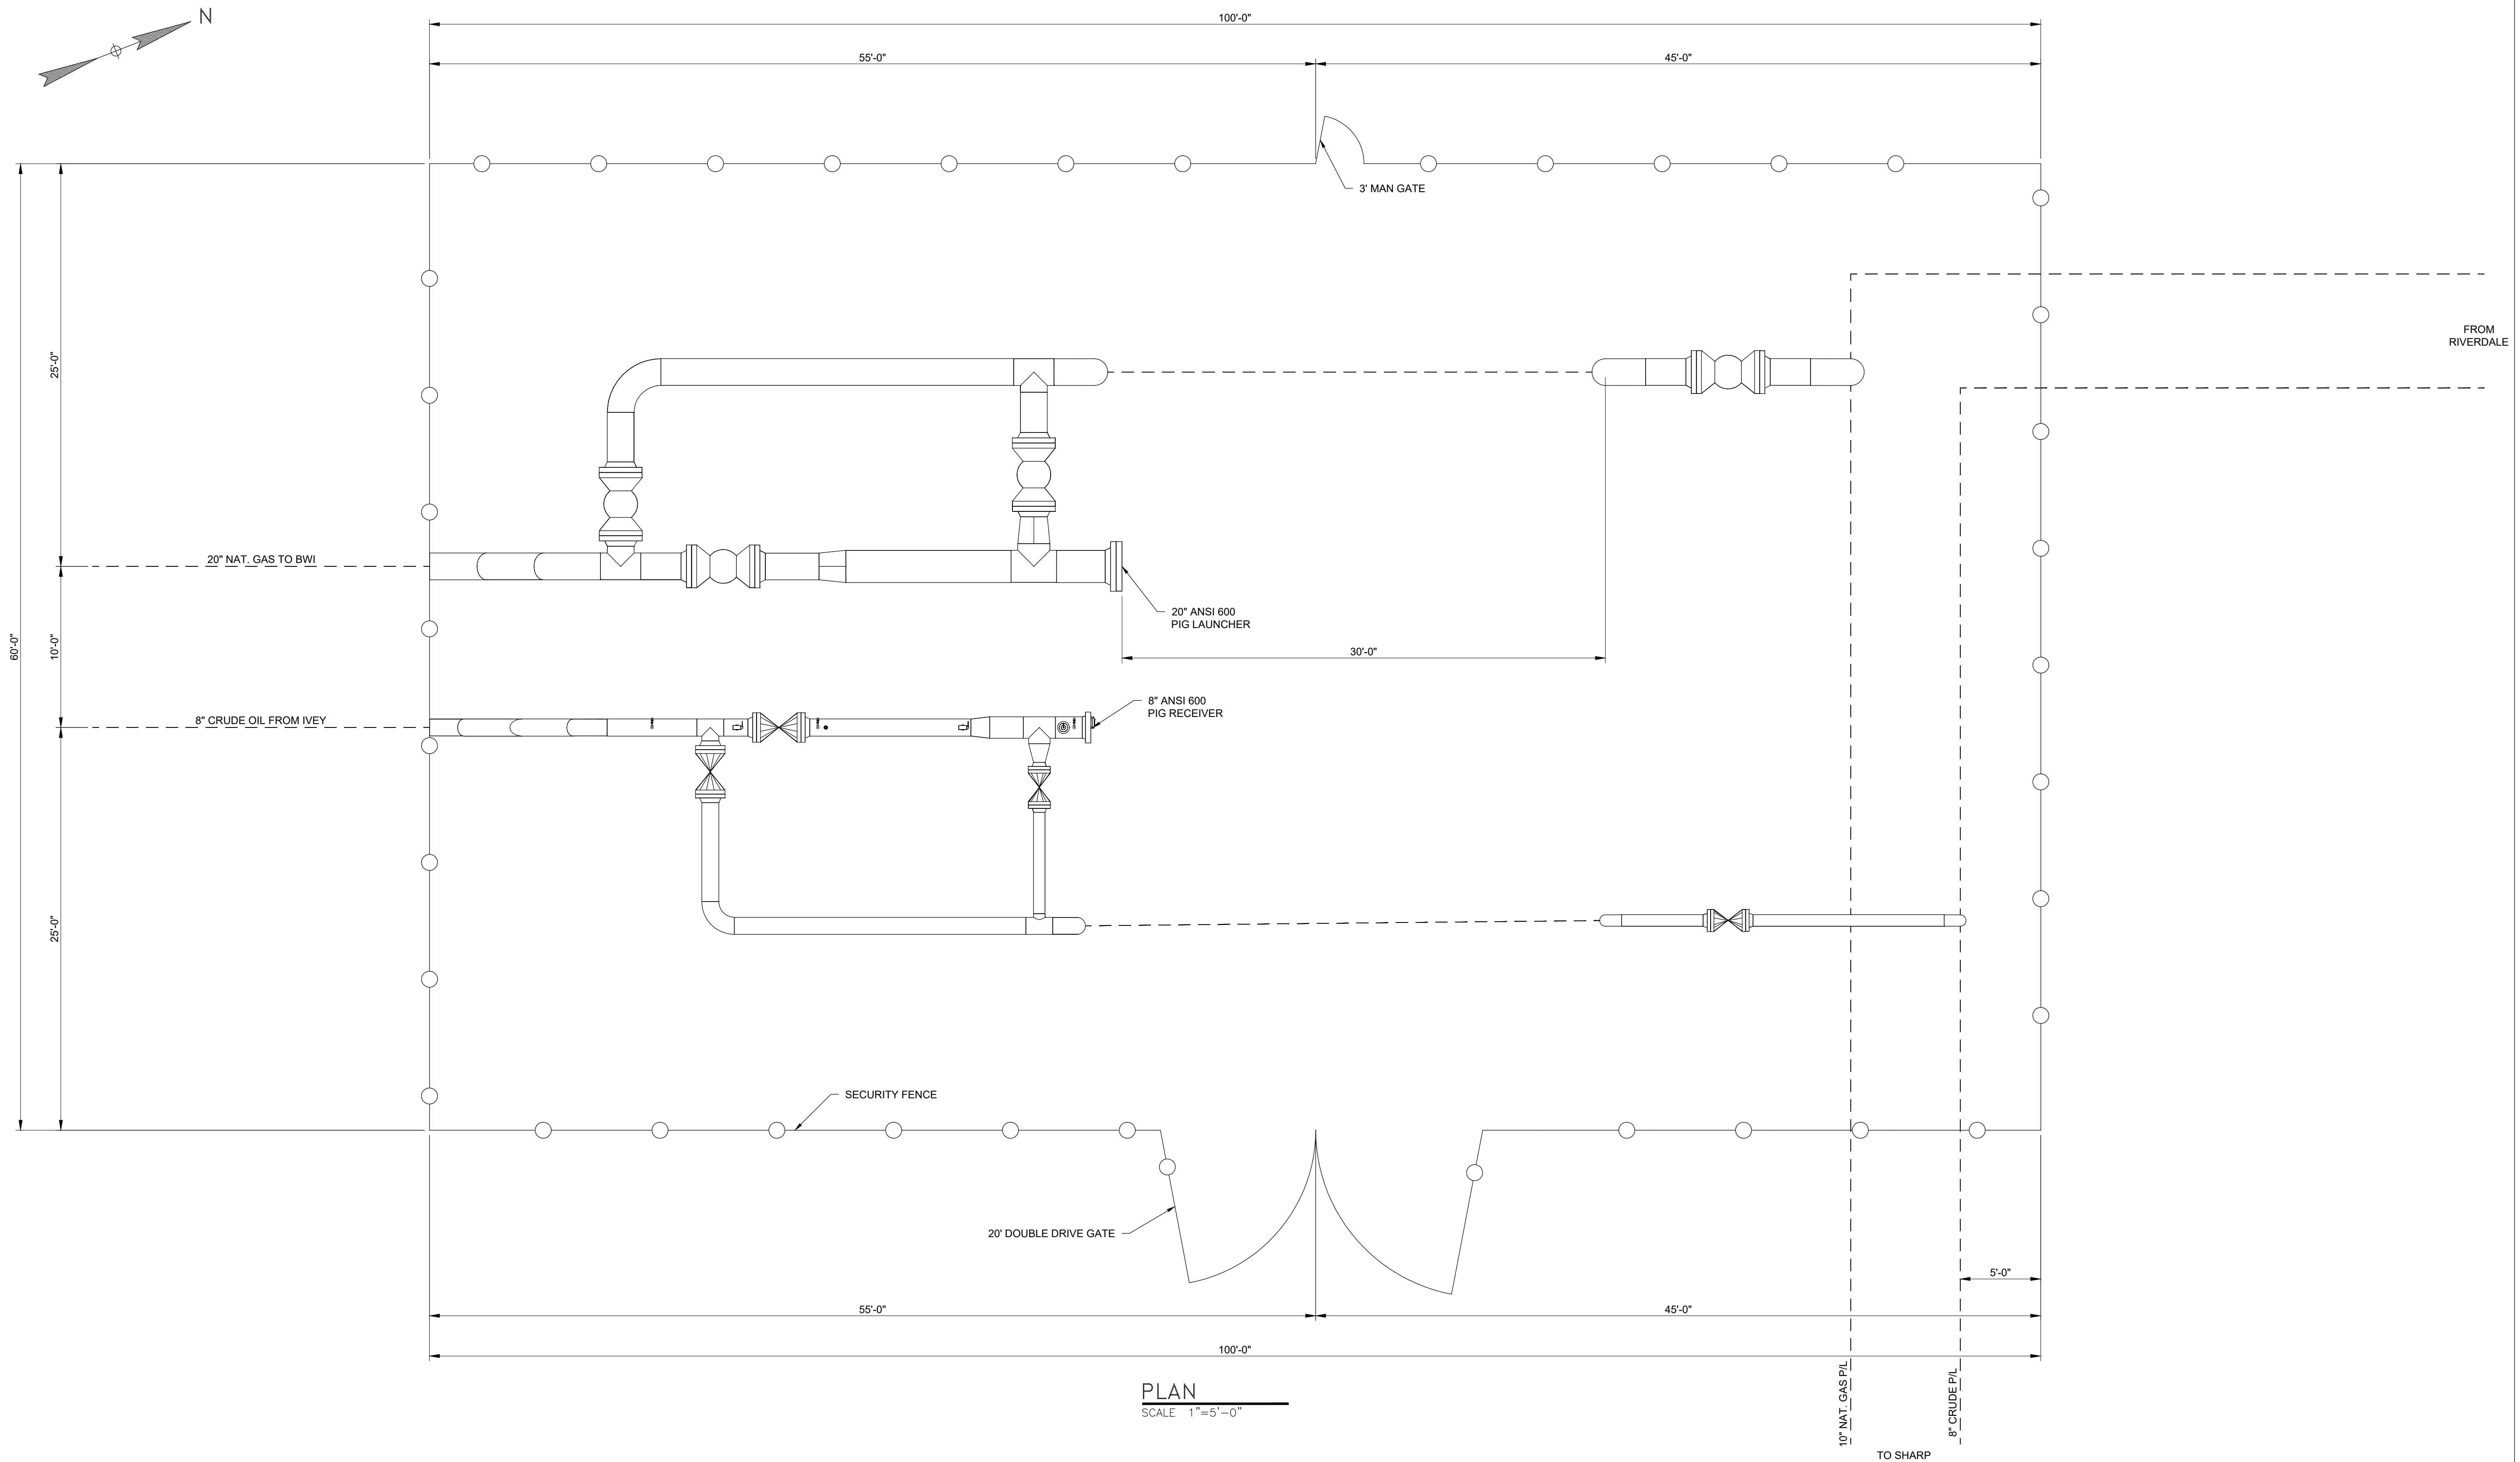

PLAN
SCALE 1"=5'-0"

NOTES:
1.

REFERENCE DRAWINGS		REVISIONS			
DRAWING NO	DESCRIPTION	No	DESCRIPTION	BY	DATE
		A	ISSUED WITH CUP APPLICATION	JRH	03/10/17
				CC	
				ALS	
				CHKD	
				APPRVD	

DISCOVERY
ZION ENGINEERING, LLC

8100 E. Maplewood Ave., Suite 100
Greenwood Village, CO 80111
303-243-3050

DISCOVERY DJ SERVICES, LLC.

BOARDWALK PIPELINE PROJECT
RIVERDALE TIE-IN FACILITY
SITE PLAN

SCALE: AS SHOWN DRAWING NO: 17009-G-XXXX REV: A