


P:\Discovery Midstream\17009 - Discovery Phase II Detailed Engineering\CAD\STA\SHTS\Gen\17009-G-XXXX.dwg Jeff Hillman 3/8/2017 2:13:44 PM

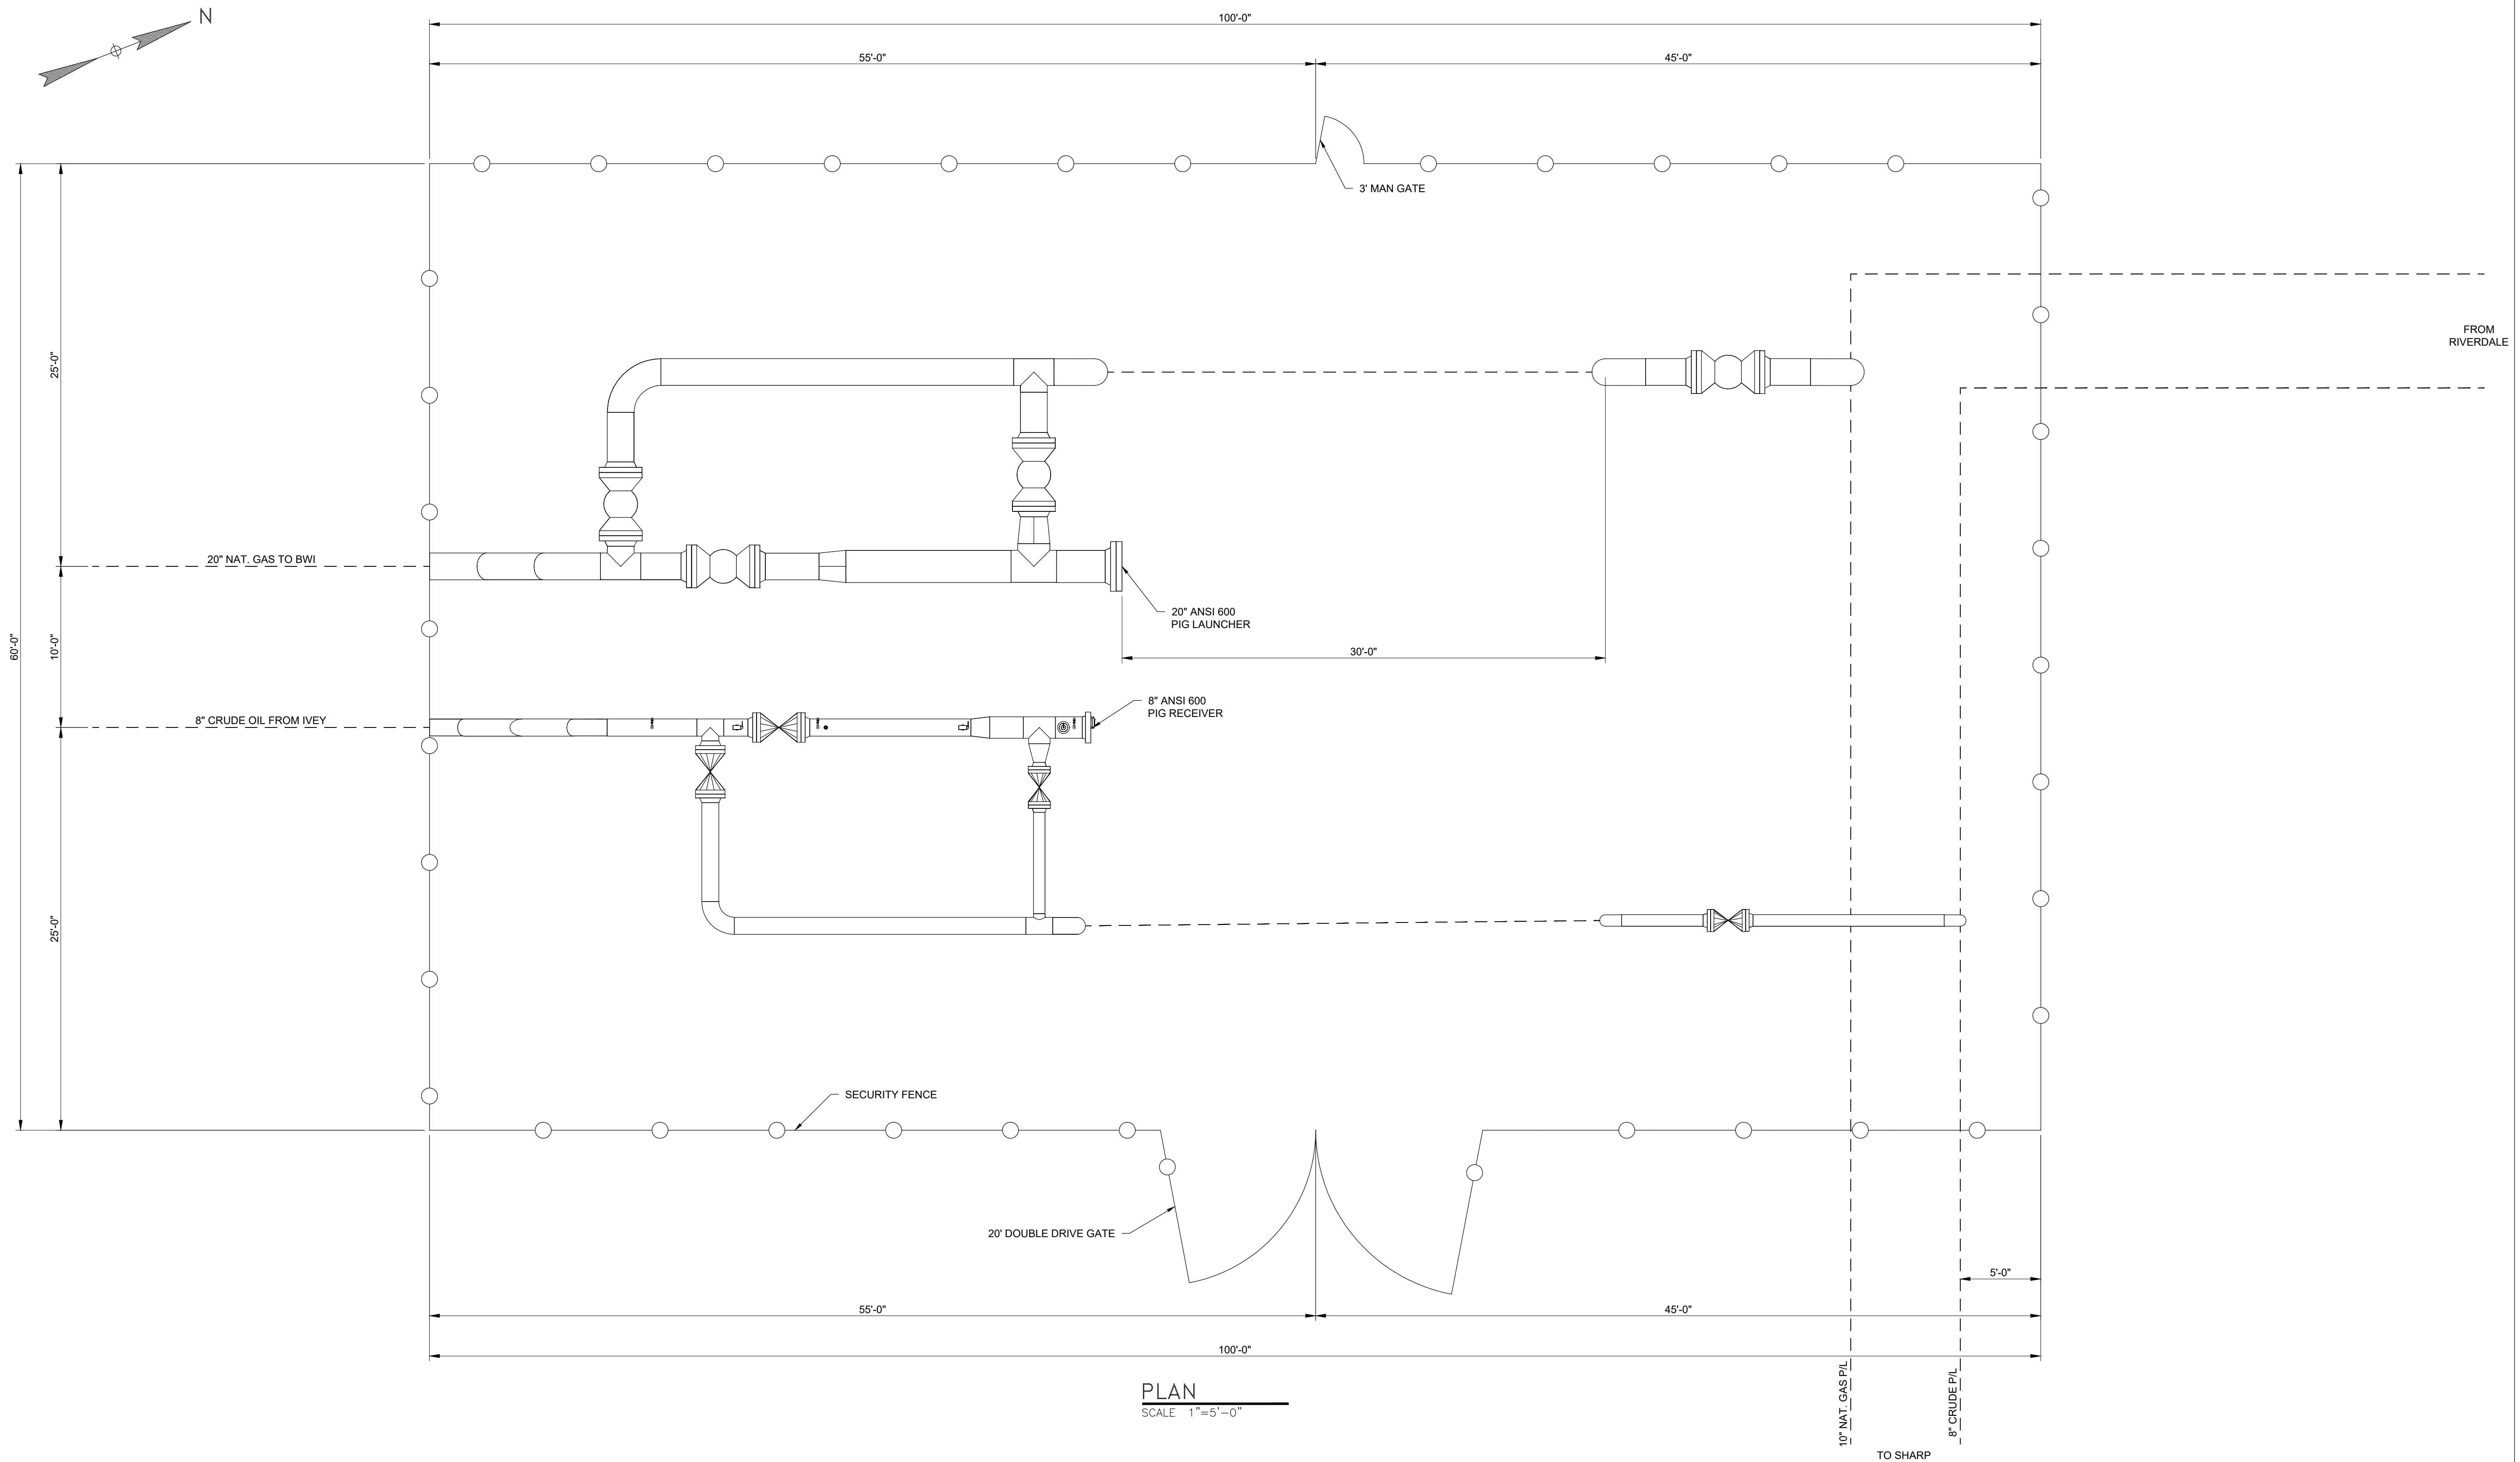

PLAN  
SCALE 1"=5'-0"

NOTES:  
1.

REFERENCE DRAWINGS		REVISIONS			
DRAWING NO	DESCRIPTION	No	DESCRIPTION	BY	DATE
		A	ISSUED WITH CUP APPLICATION	JRH	03/10/17
				CC	
				ALS	
				CHKD	
				APPRD	

**DISCOVERY**  
**ZION ENGINEERING, LLC**

8100 E. Maplewood Ave., Suite 100  
Greenwood Village, CO 80111  
303-243-3050

**DISCOVERY DJ SERVICES, LLC.**

BOARDWALK PIPELINE PROJECT  
RIVERDALE TIE-IN FACILITY  
SITE PLAN

SCALE: AS SHOWN      DRAWING NO: 17009-G-XXXX      REV: A